



900 > 23.99' 45"
 54.00 > 23.99' 45"
 177 > 16.5' 45"
 45.22.6.111 X ENGR
 1.-CONTRACT 0.2016
 14589000776.222
 776.22214589000
 8900076.222.480
 9822.8798 | 432
 8222.8798 | 432

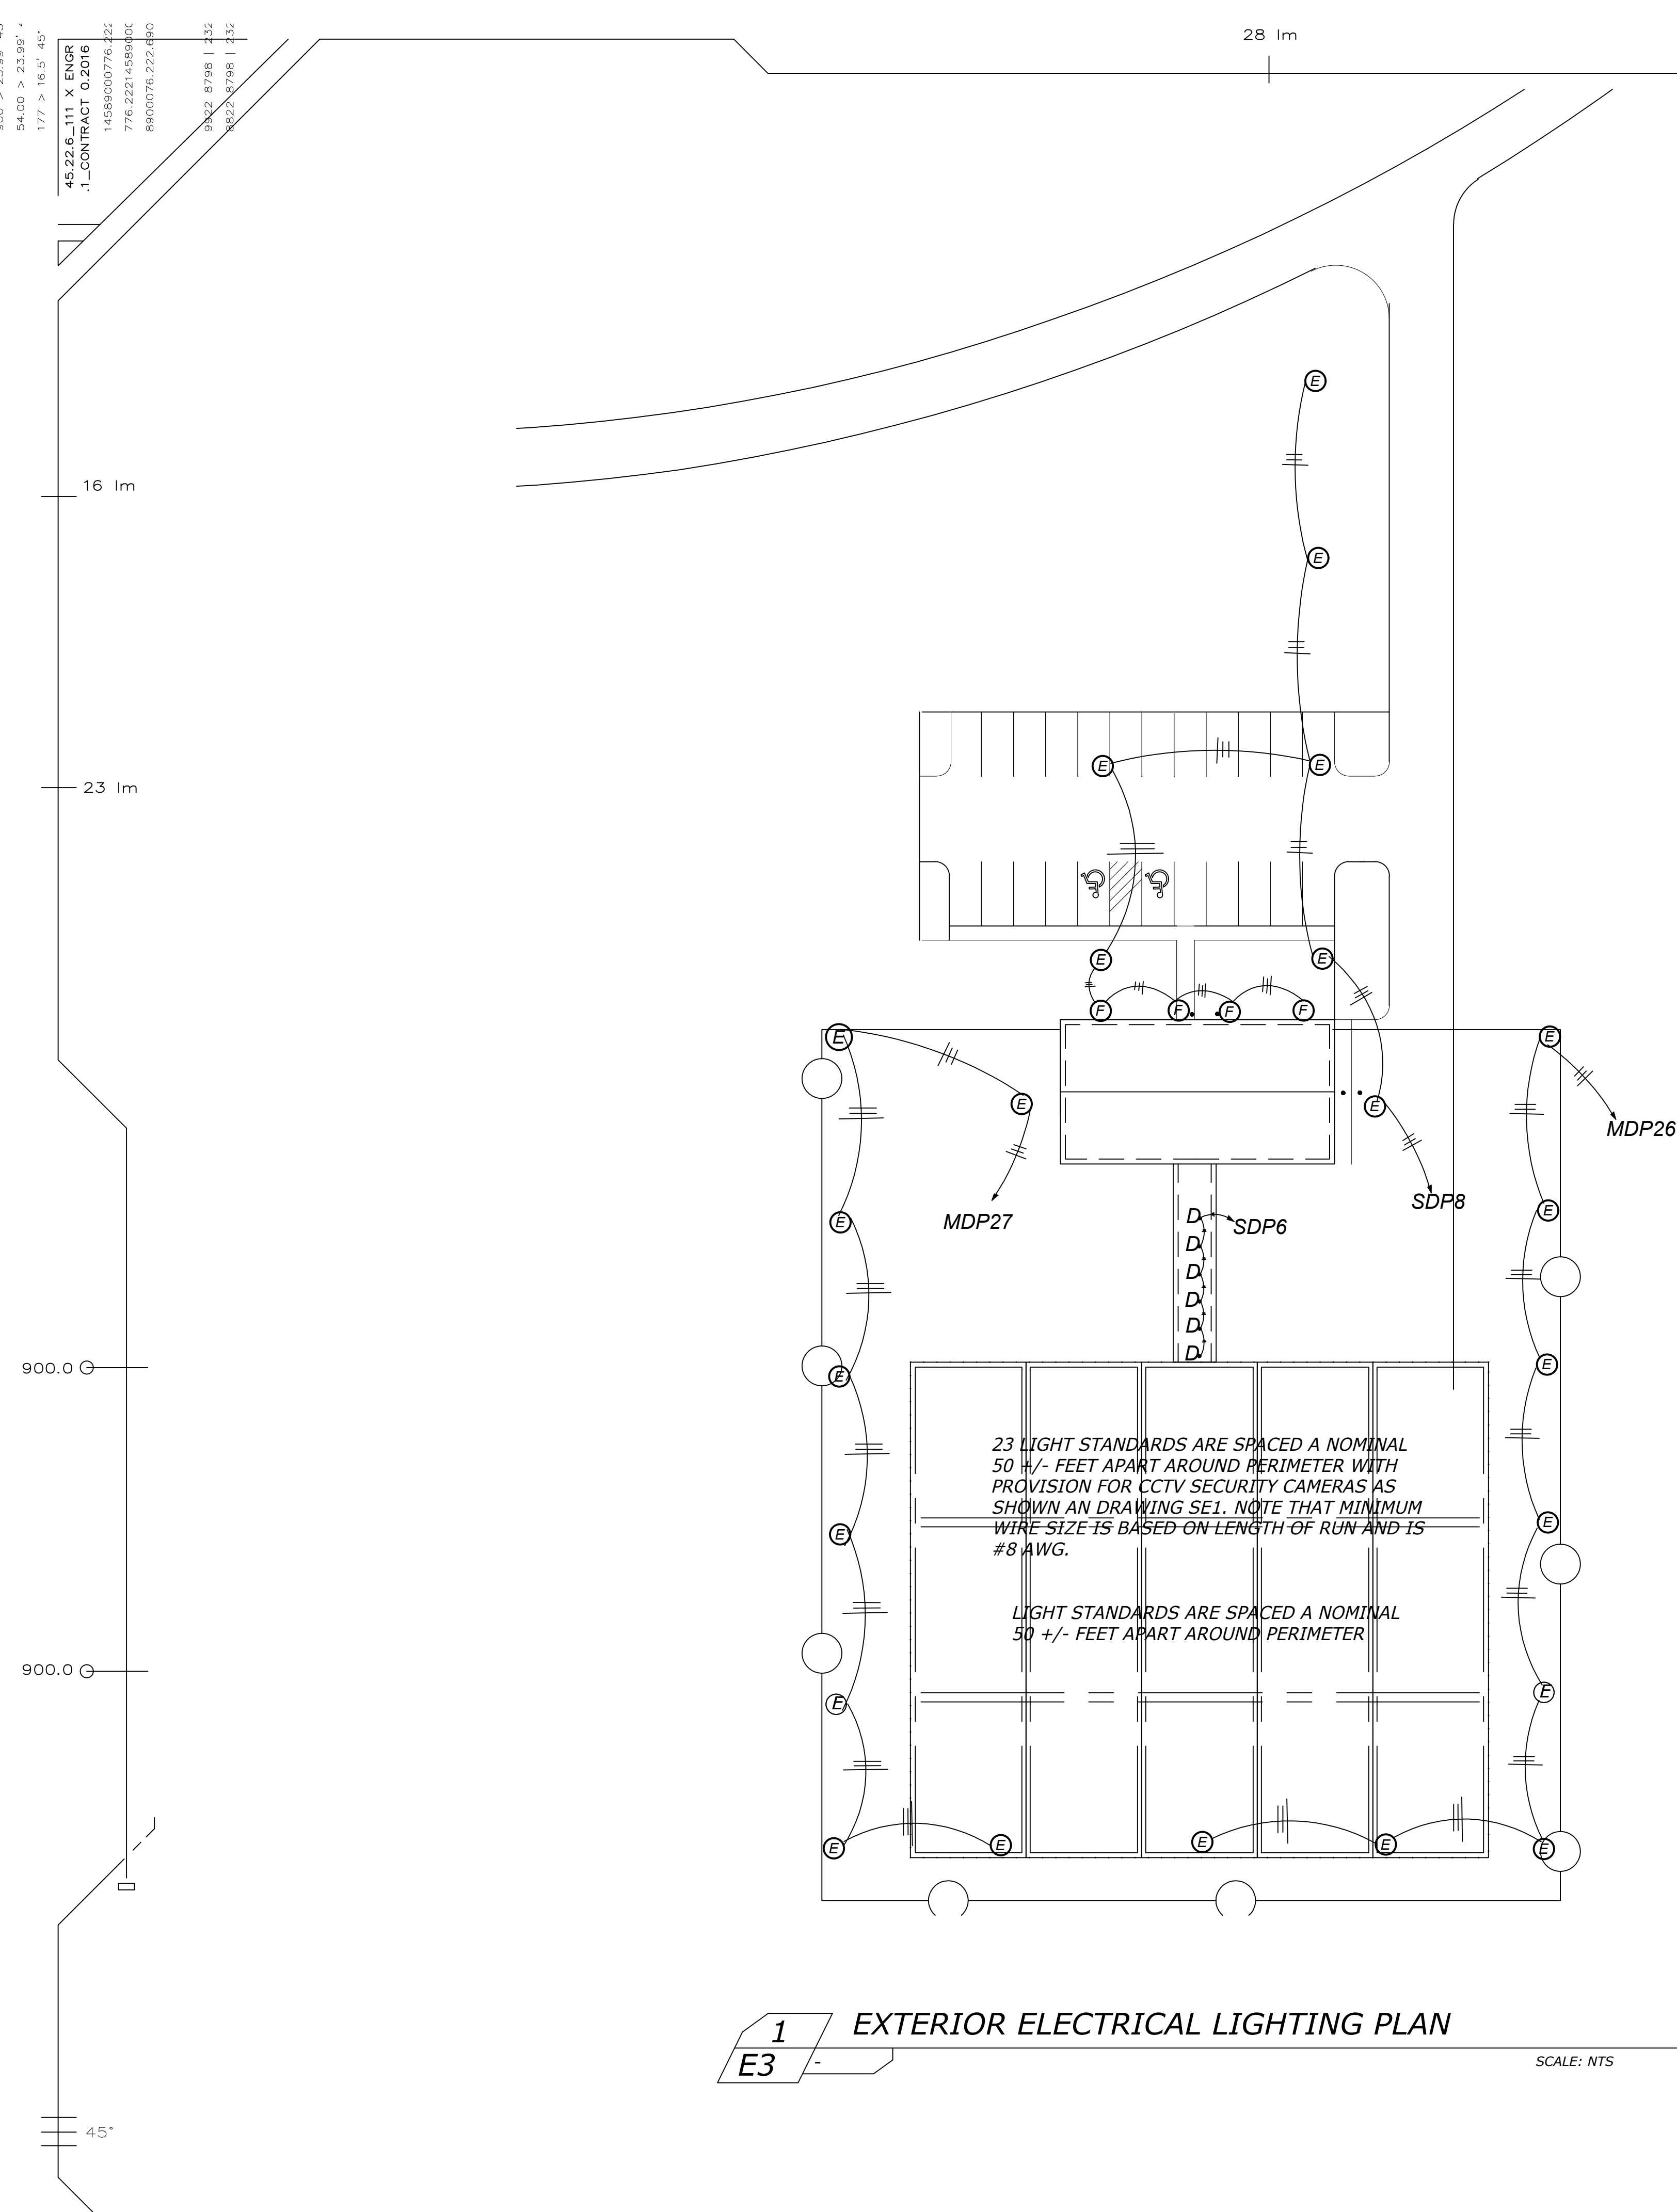

1 EXTERIOR ELECTRICAL LIGHTING PLAN
 E3

SCALE: NTS

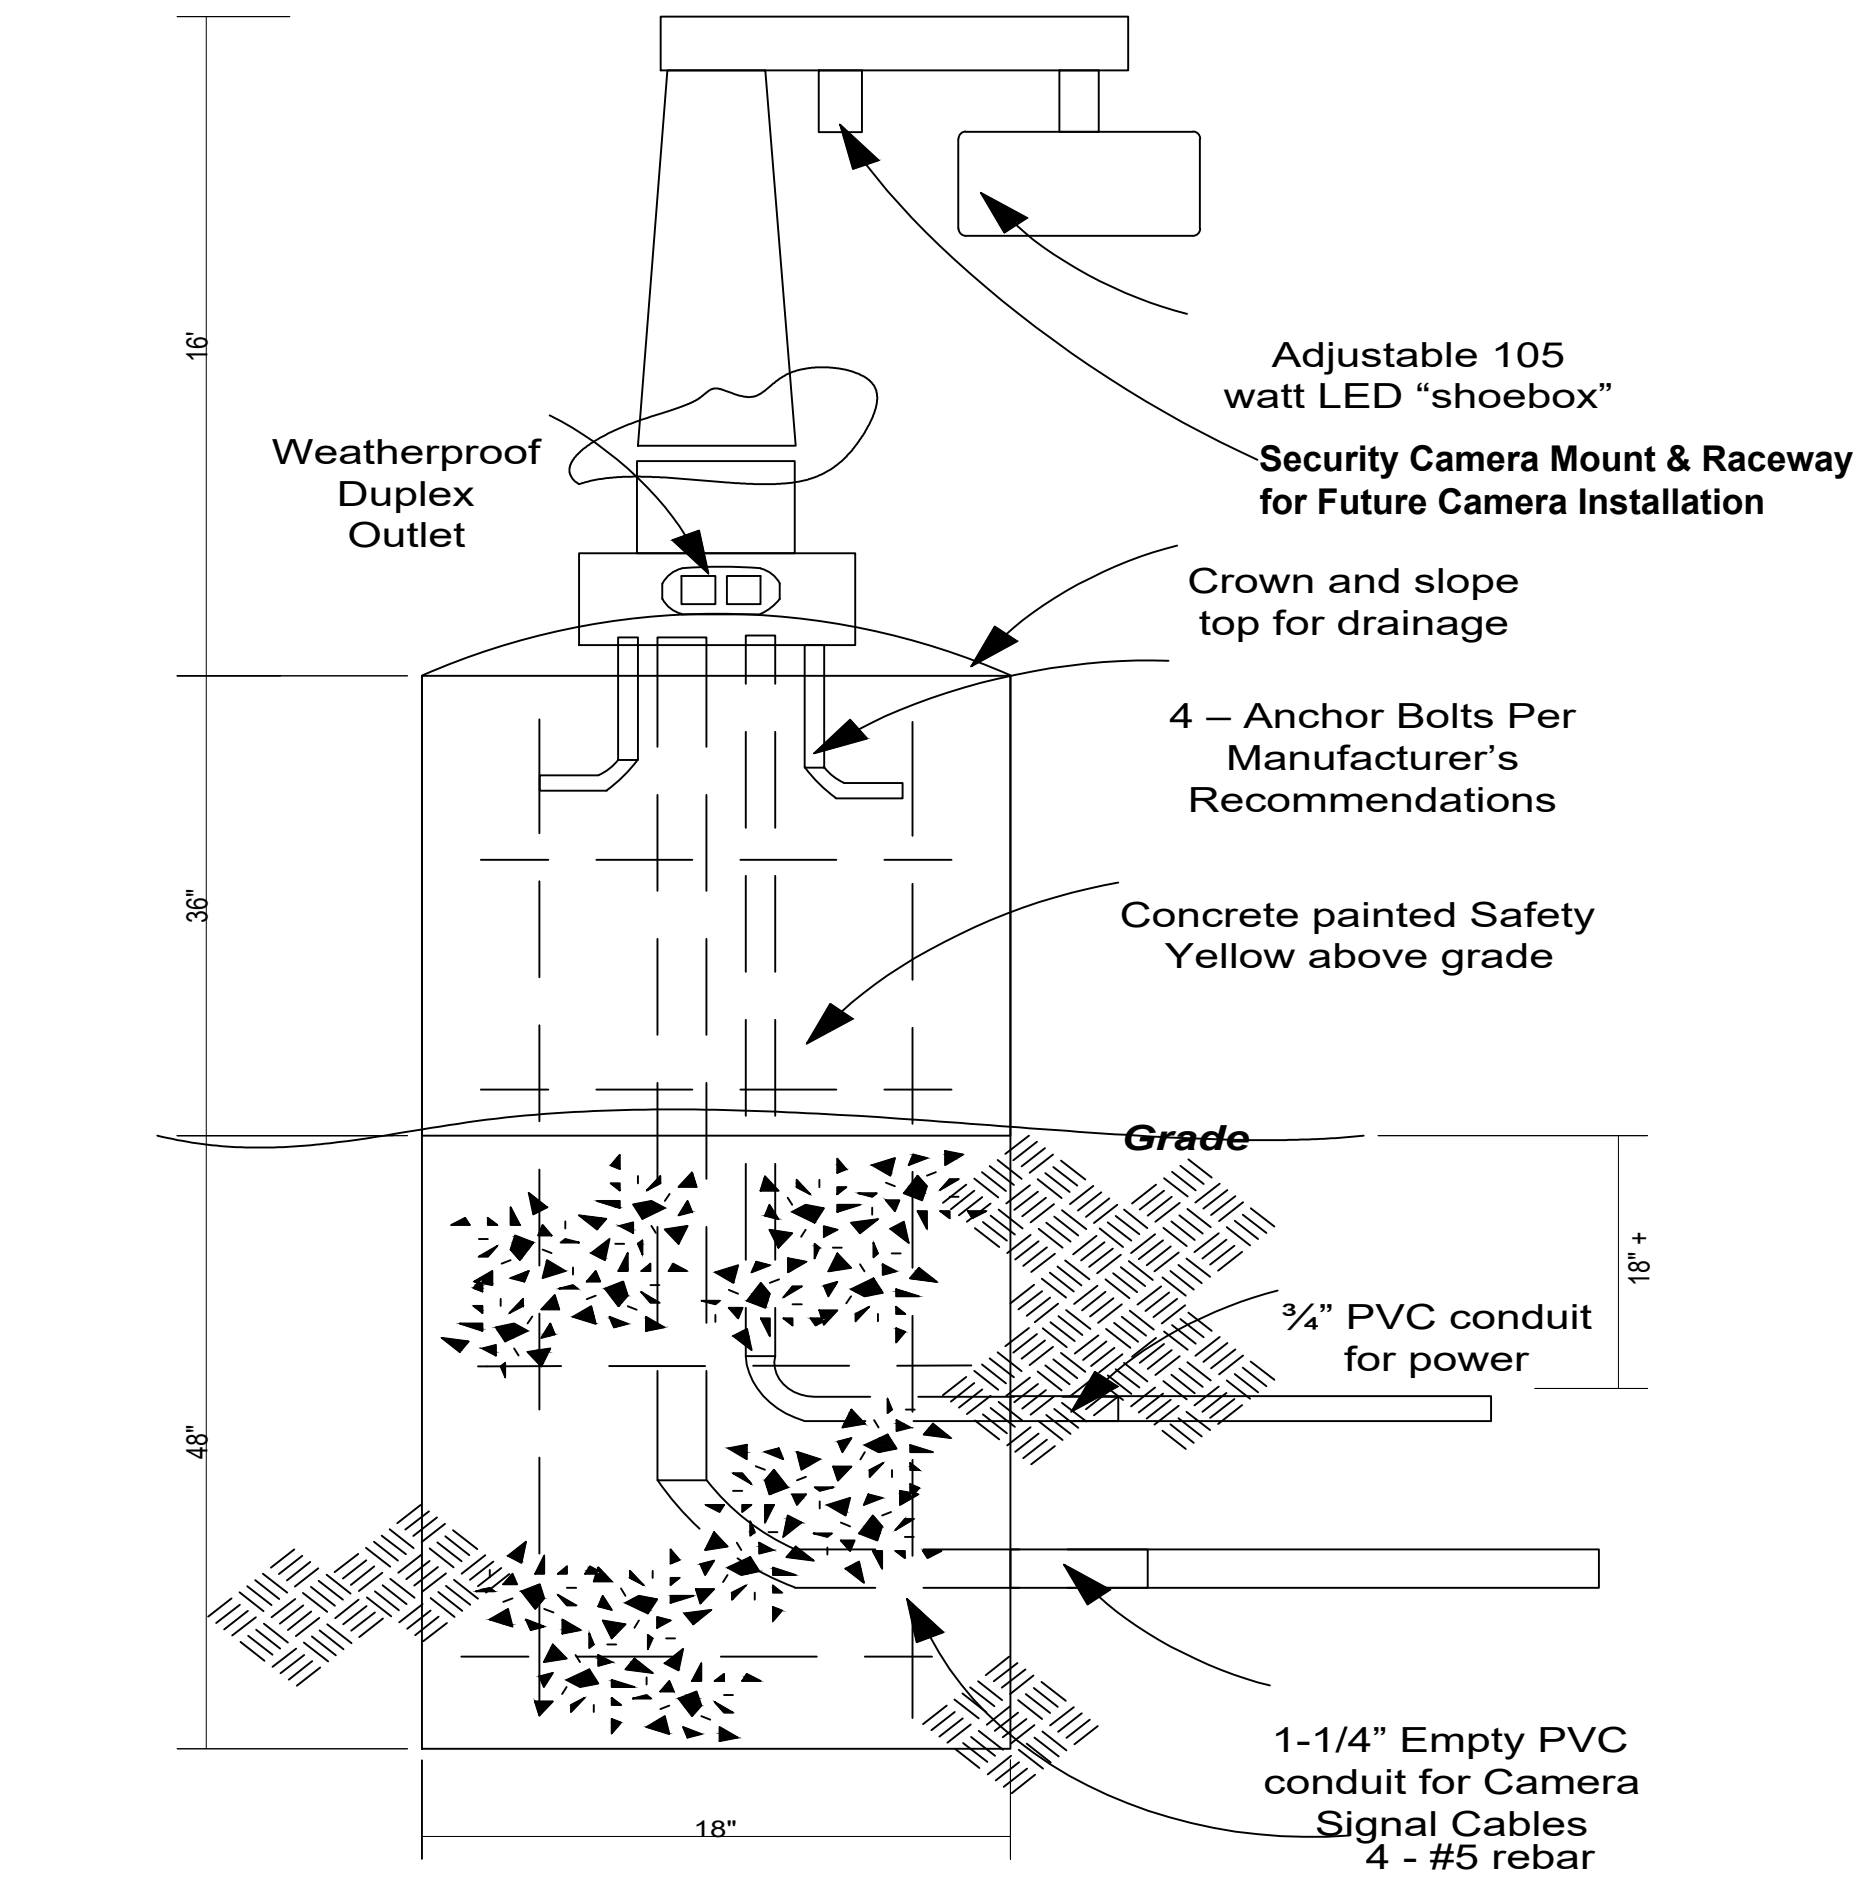

2 Parking Lot Pole Detail
 E3

SCALE: NTS

AE LEUKEN, LLC
 ARCHITECTURAL ENGINEERS
 1122 N. EL PASO ST
 COLORADO SPRINGS CO, 80903
 PHONE : (719) 398 1155

MILE HIGH ROSE LLC
 180 COUNTY RD 599
 WALSENBURG, CO 81089

NO.	DATE	DESCRIPTION

DATE: XX/XX/XXXX
 CHECKED BY: JYG
 PROJECT NO: PROJECT#
 SHEET: EXT LIGHTING PLAN

E3