

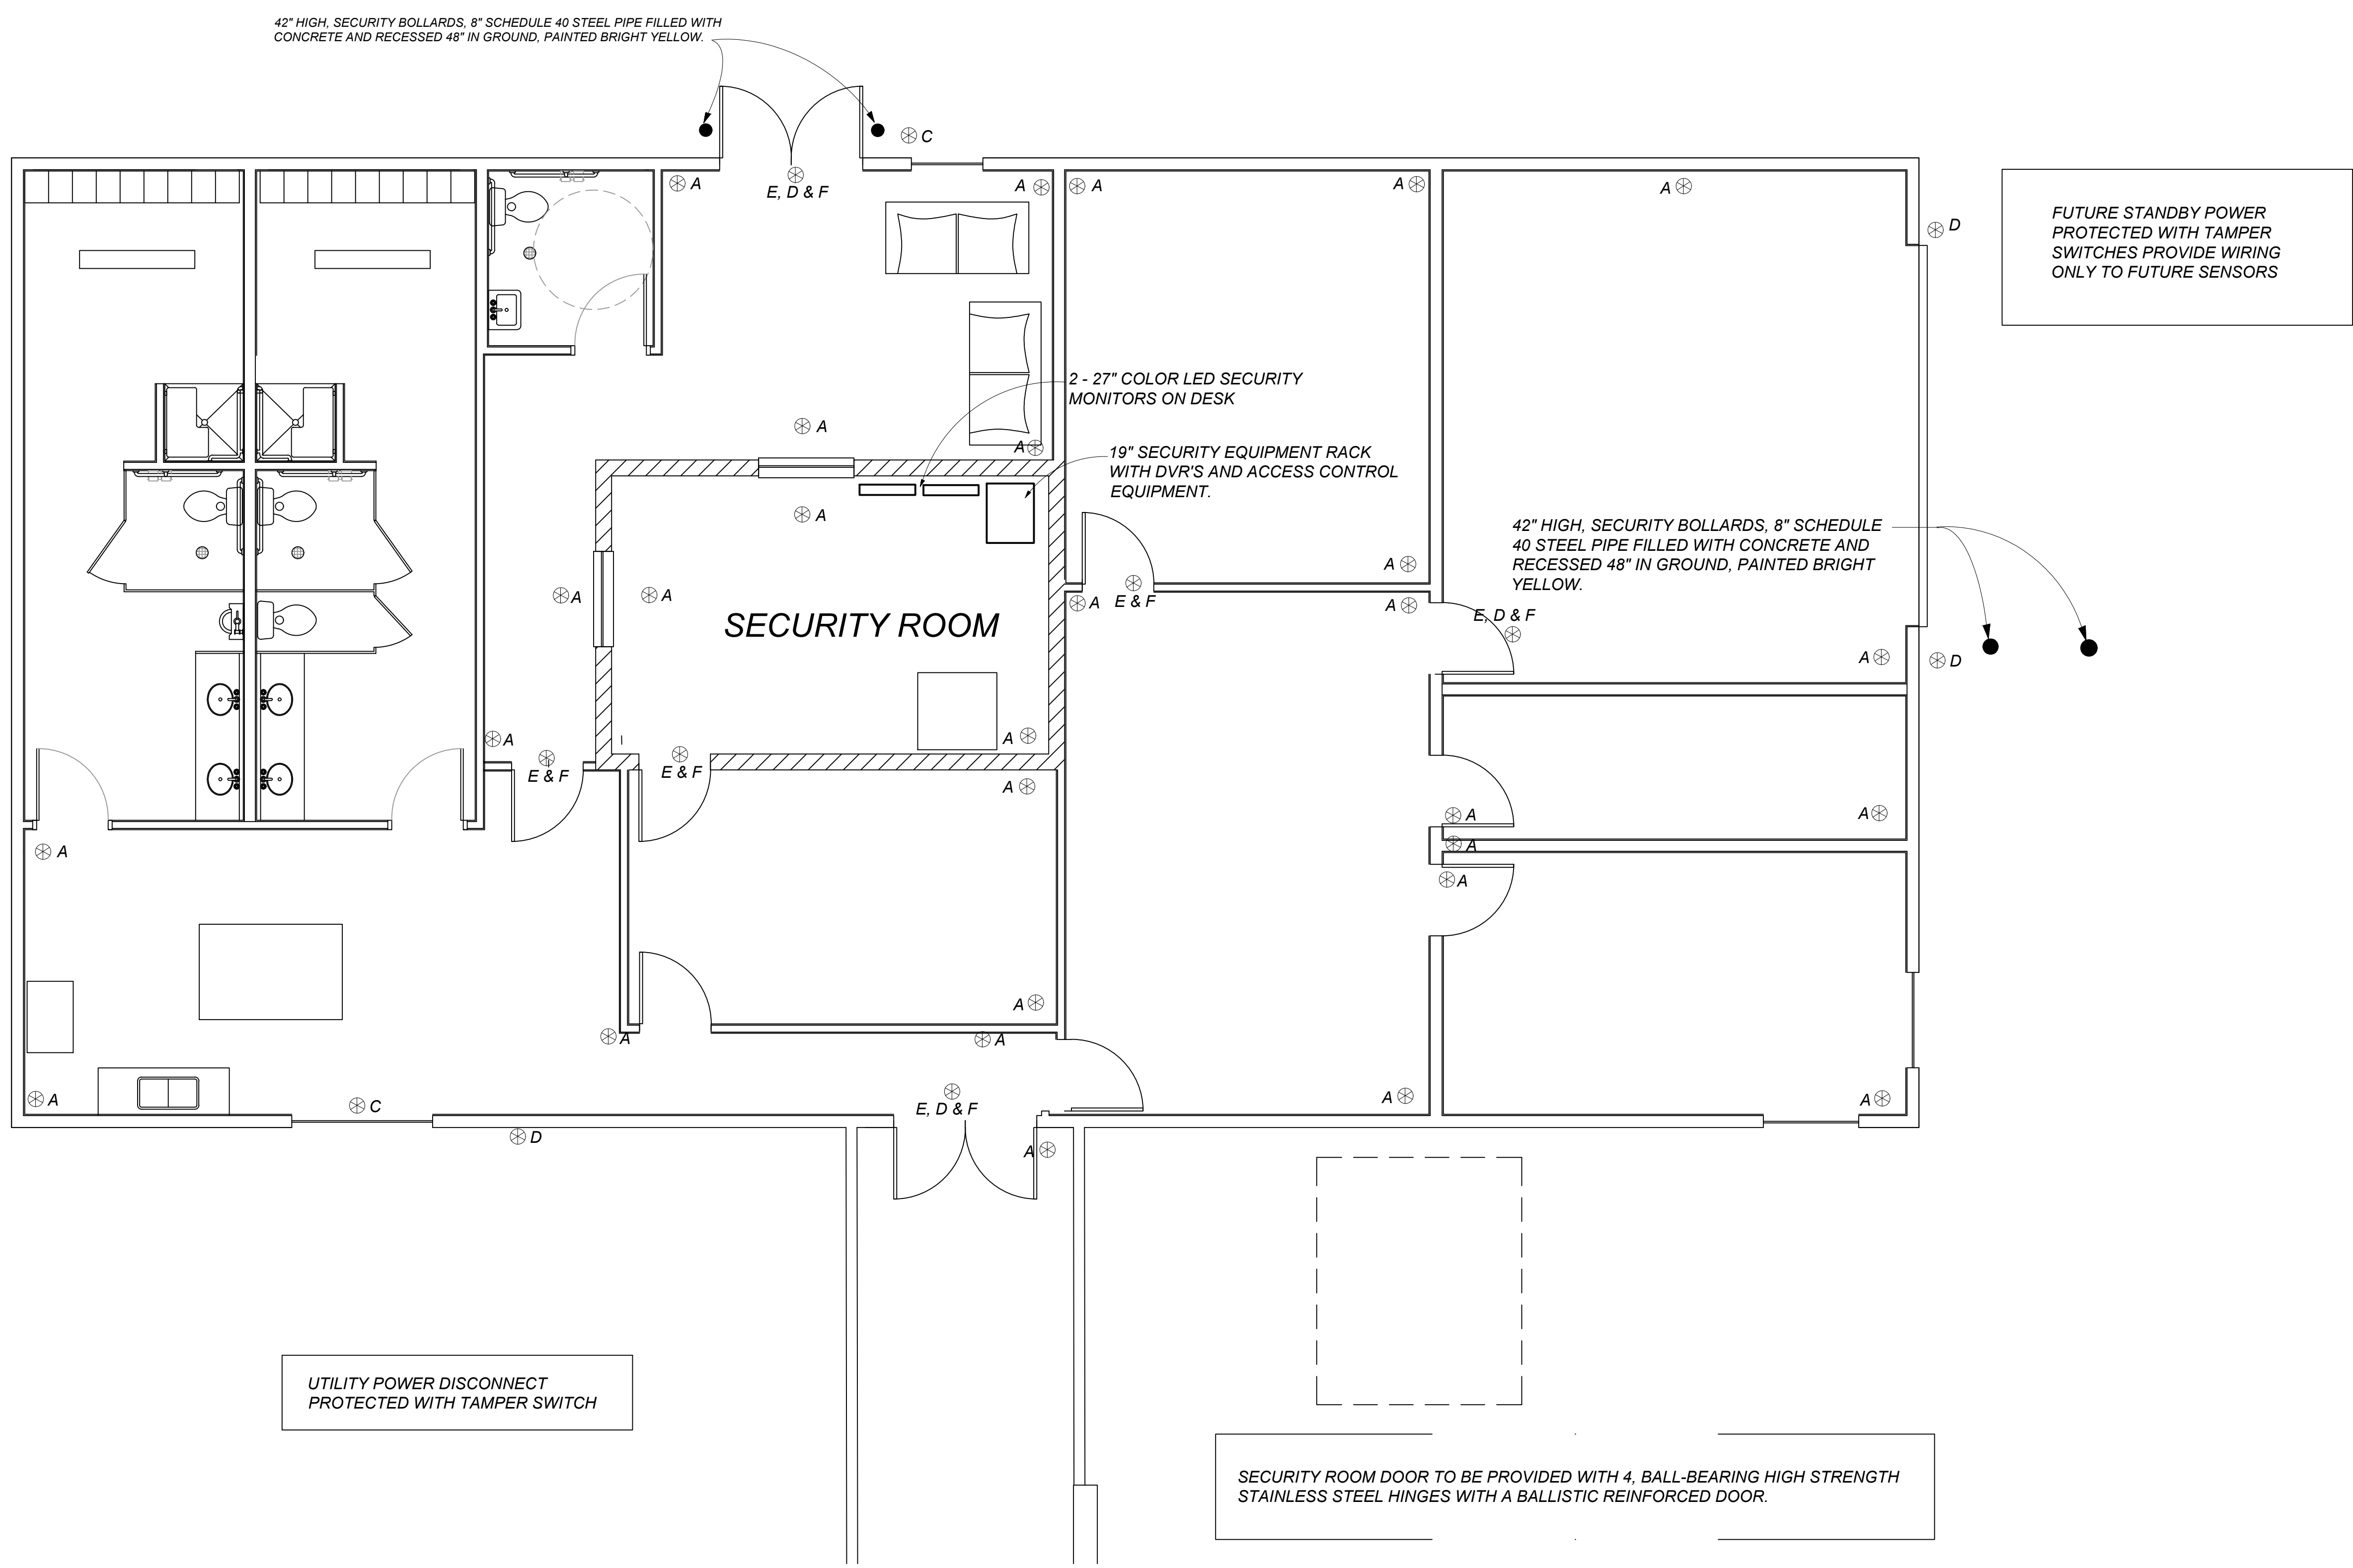


900 > 23.99' 45"
 54.00 > 23.99' 45"
 177 > 16.5' 45"
 45.22.6_111 X ENGR
 1._CONTRACT 0.2016
 14589000776.221
 776.2221498940C
 8900076.222.480
 9822.8798 | 135
 8222.8798 | 132
 16 im
 23 im
 900.0 G
 900.0 G
 45°

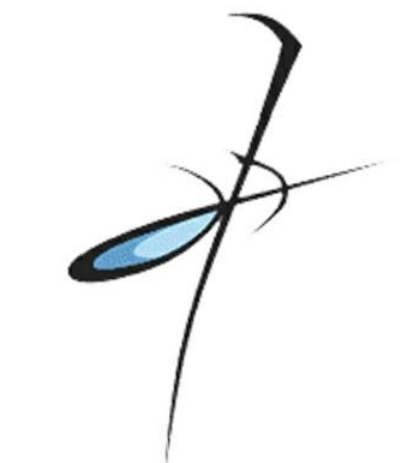

1 SECURITY PLAN
 ES2

SCALE: 1/4" = 1'-0"

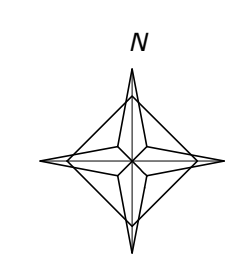

AE LEUKEN, LLC
 ARCHITECTURAL ENGINEERS

1122 N. EL PASO ST
 COLORADO SPRINGS CO, 80903
 PHONE : (719) 398 1155

MILE HIGH ROSE LLC
 180 COUNTY RD 599
 WALSENBURG, CO 81089

NO.	DATE	DESCRIPTION

DATE: XX/XX/XXXX
 CHECKED BY: JJG
 PROJECT NO: PROJECT#
 SHEET: SECURITY PLAN

ES2