



AE LEUKEN, LLC
ARCHITECTURAL ENGINEERS

1122 N. EL PASO ST
COLORADO SPRINGS CO, 80903
PHONE : (719) 398 1155


MILE HIGH ROSE LLC
180 COUNTY RD 599
WALSENBURG, CO 81089

NO.	DATE	DESCRIPTION

DATE:	XX/XX/XXXX
CHECKED BY:	JJG
PROJECT NO:	PROJECT#
SHEET:	ROOF HVAC PLAN

M3

900 > 23.99' 45
54.00 > 23.99' 45
177 > 16.5' 45
45.22.6.111 X ENGR
.1_CONTRACT 0.2016
1458900776.222
776.2221458900C
8900076.222.480
9822.8798 | 435
8222.8798 | 432
900.0 G
900.0 G
45°

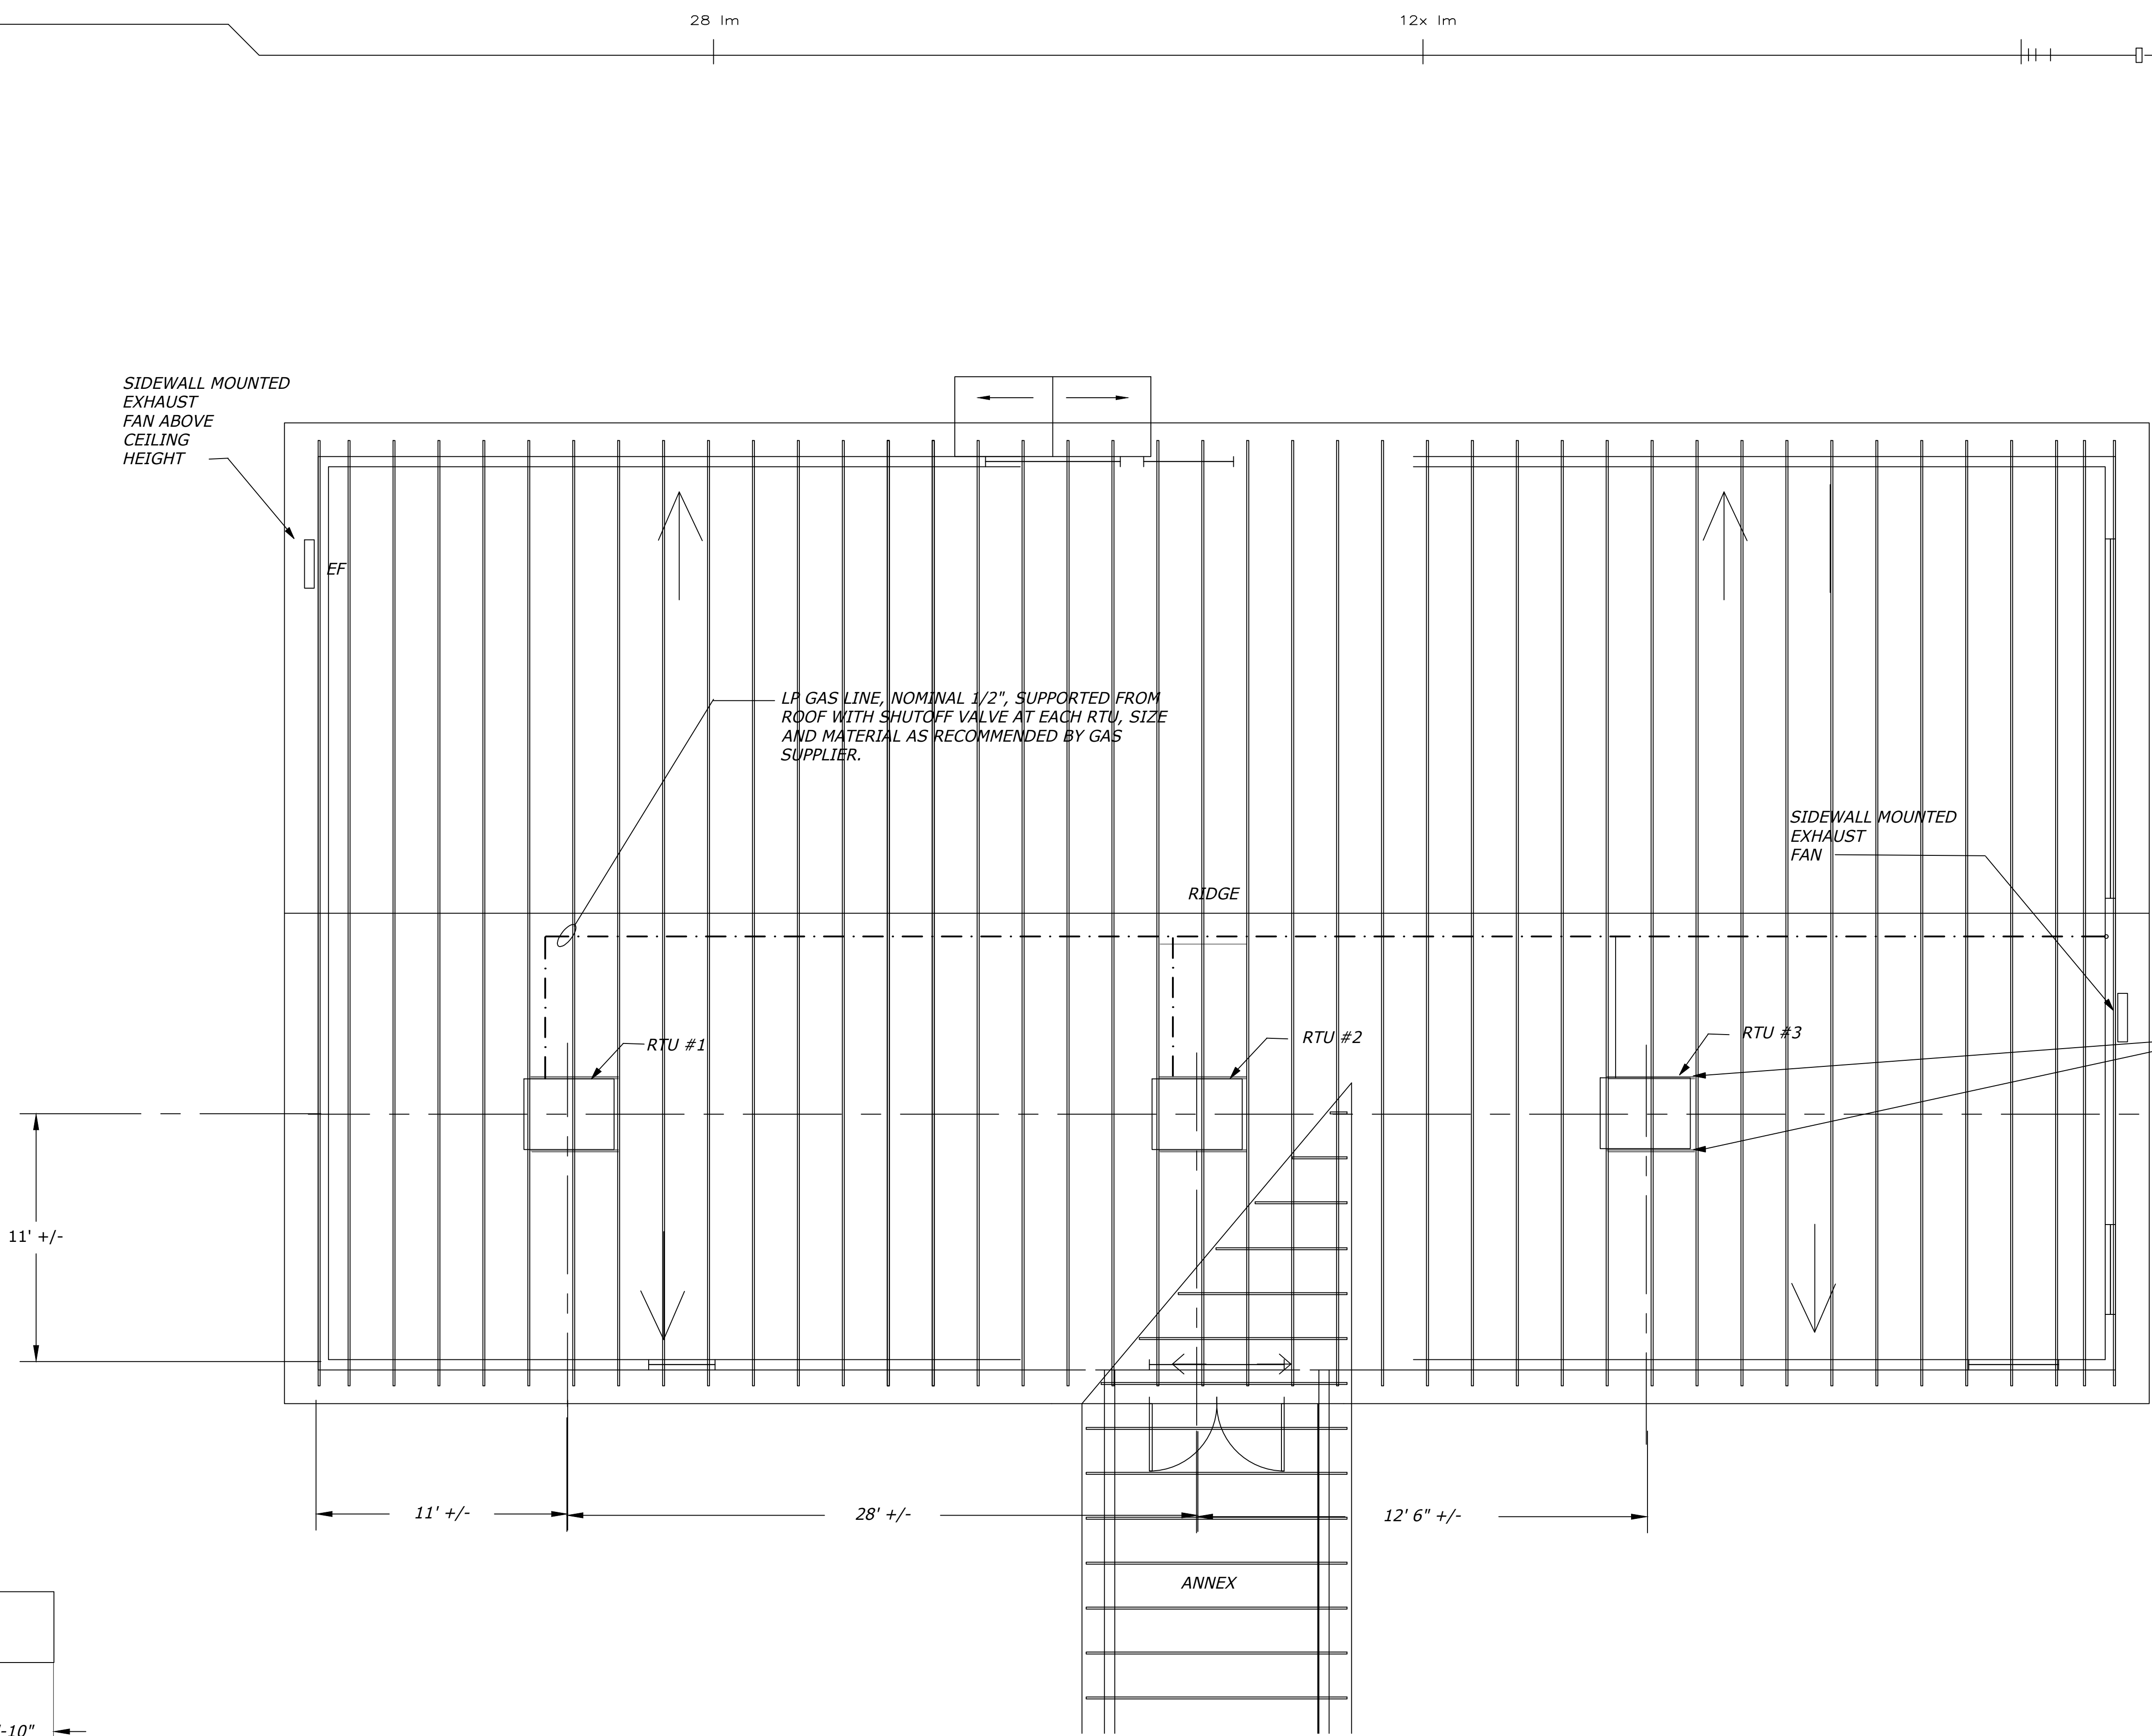

1 ROOF HVAC PLAN
M3 SCALE: 1/4" = 1'-0"