



**AE LEUKEN, LLC**  
ARCHITECTURAL ENGINEERS


1122 N. EL PASO ST  
COLORADO SPRINGS CO, 80903  
PHONE : (719) 398 1155

**MILE HIGH ROSE LLC**  
180 COUNTY RD 599  
WALSENBURG, CO 81089

NO.	DATE	DESCRIPTION

DATE:	05/15/2017
CHECKED BY:	JJG
PROJECT NO:	14-2017
SHEET:	DRAIN & LPG PLAN

**P1**

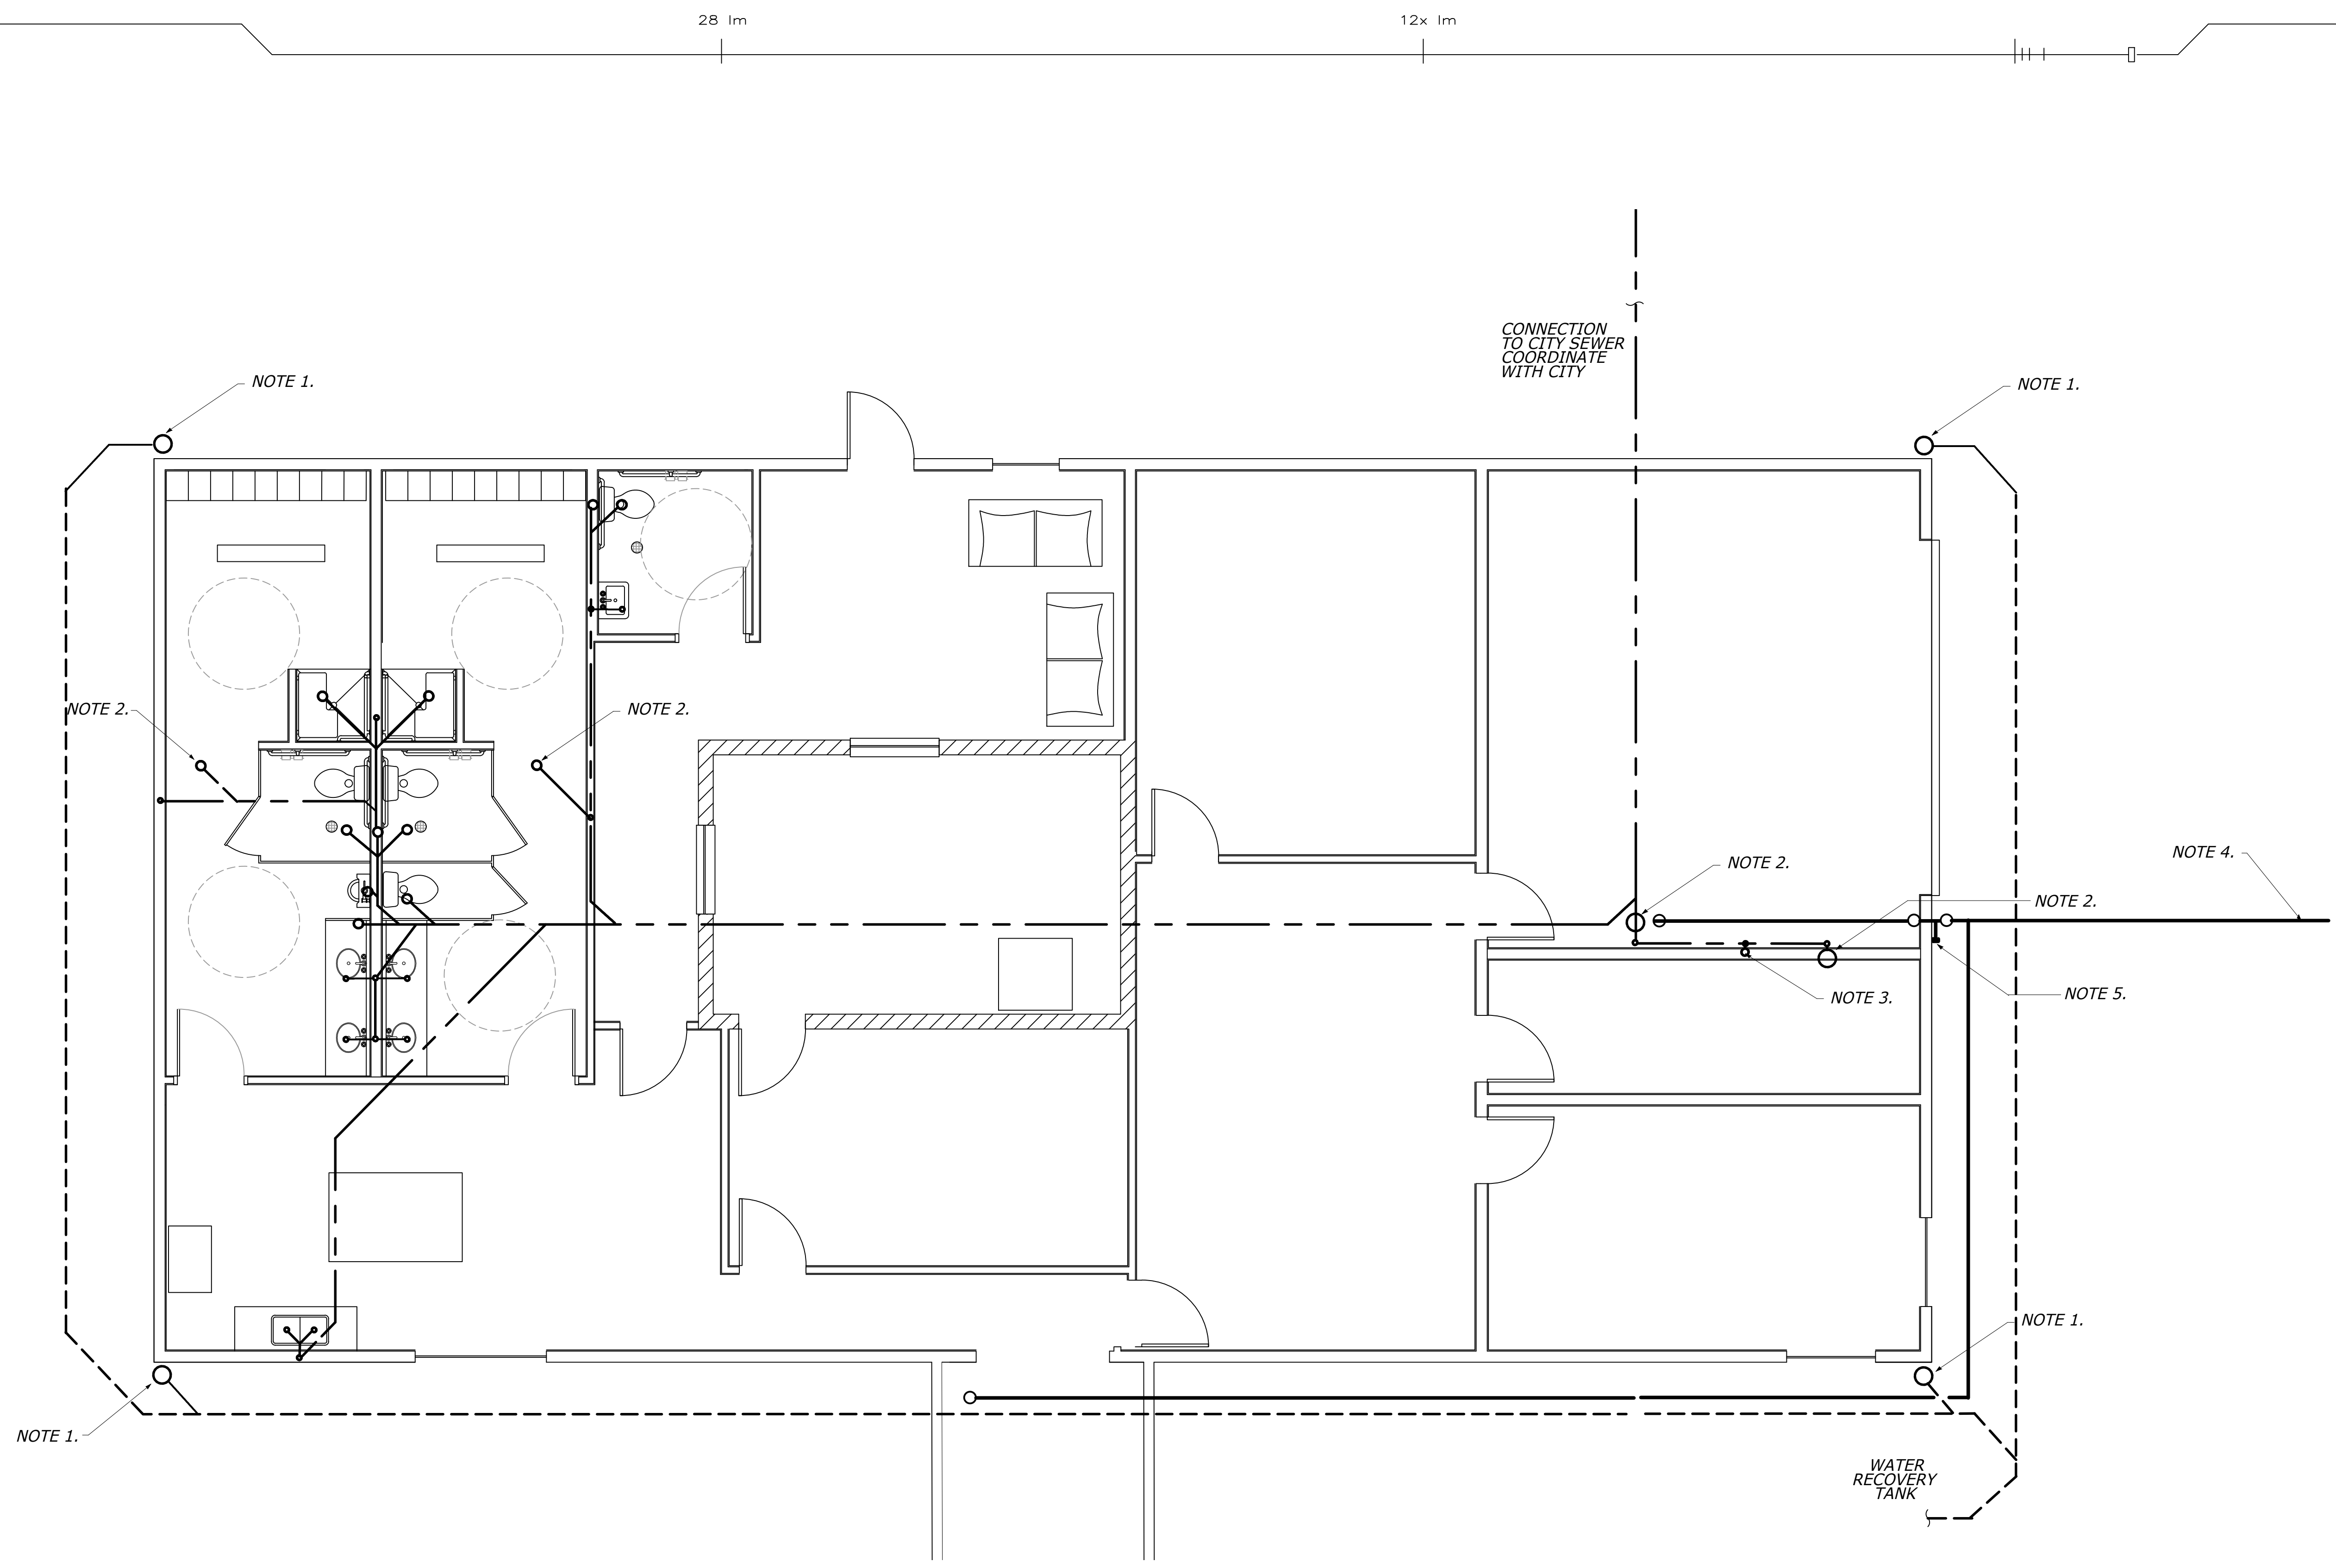

- NOTES:**
- 4" DRAIN FOR RECEIVING DOWNSPOUT WATER.
  - 4" FLOOR DRAIN IN SLAB.
  - 2" RISER FOR WASHER DISCHARGE.
  - LPG LINE SIZE AND MATERIAL AS RECOMENDED BY LPG SUPPLIER.
  - 1" LPG LINE CONNECTION CAPPED FOR FUTURE ENGINE GENERATOR CONNECTION.
  - FOR PIPE SIZES SEE RISER DIAGRAM ON DRAWING P4.

**1**  
**P1** **DRAIN AND LPG PIPING PLAN** SCALE: 1/8" = 1'-0"

**LEGEND:**

- LPG LINE
- WATER DAINAGE LINE
- SEWER LINE

900 > 23.99' 45  
54.00 > 23.99' 4  
177 > 16.5' 45  
45.22.6.111 X ENGR  
1. CONTRACT 0.2016  
14588000776.222  
776.22214588000  
8900076.222.480  
9822.8798 | 432  
8222.8798 | 432  
16 m  
23 m  
900.0  
900.0  
45°

28 m 12x 1m