

Oversight / NHS

FHWA PROJECTS OF DIVISION INTEREST (PoDI) OVERSIGHT?  NO  YES

NATIONAL HIGHWAY SYSTEM?  NO  YES

# DEPARTMENT OF TRANSPORTATION STATE OF COLORADO

Related Projects:  
P. E. UNDER PROJECT: SRM R200-231  
Project Number: 21393  
Project Code:  
R.O.W. Projects:  
R.O.W. Project Description



### TABULATION OF LENGTH & DESIGN DATA

STATION	FEET		MAJOR STR.
	ROADWAY NB SH 45	ROADWAY SB SH 45	
APPROACH TO PROJECT M.P. 4.65			
BEGIN STM SH 45-001= BEGIN ASPHALT RESURFACING STA 8+15, M.P. 4.9	2659.0	2659.0	
BEGIN STRUCTURE K-18-EP, STA 34+74.00 END STRUCTURE K-18-EP, STA 39+07.11 END ASPHALT RESURFACING BEGIN CONCRETE REBUILD	4551.6		434.0
BEGIN STRUCTURE K-18-EU NB, STA 84+58.72 END STRUCTURE K-18-EU NB, STA 86+11.97			
END CONCRETE REBUILD, BEGIN CONCRETE FDR NB, STA 86+33.35	23.4		153.3
BEGIN STRUCTURE K-18-EV SB, STA 85+02.29 ** END STRUCTURE K-18-EV SB, STA 86+55.29**		4595.2	
END CONCRETE REBUILD, BEGIN CONCRETE FDR SB, STA 86+86.08		30.8	153.0
END CONCRETE FDR, BEGIN CONCRETE REBUILD STA 197+78.53	11143.2	11092.5	
END STM SH 45-001= END CONCRETE REBUILD STA 200+66.00, M.P. 8.55	287.5	287.5	
APPROACH TO PROJECT M.P. 8.95			
<b>TOTAL</b>	<b>18664.6</b>	<b>18664.9</b>	<b>587.3</b>
<b>SUMMARY OF PROJECT LENGTH</b>	<b>FEET</b>	<b>FEET**</b>	<b>MILES</b>
MAJOR STRUCTURE	587.3	587.0	0.1
PROJECT GROSS LENGTH	19251.9	19252.1	3.6

\* MILE POSTS ARE ESTIMATES AND SHOULD BE VERIFIED IN THE FIELD.  
\*\* LENGTH NOT INCLUDED IN TOTAL

DESIGN DATA	S.H. 45
MAXIMUM DESIGN SPEED	65 MPH
2035 DESIGN TRAFFIC	DHV = 10 ADT = 45,711
DHV TRUCK %	4.6%

## HIGHWAY CONSTRUCTION BID PLANS OF PROPOSED FEDERAL AID PROJECT NO. STM SH45-001 STATE HIGHWAY NO. 45 PUEBLO COUNTY CONSTRUCTION PROJECT CODE NO. 20755

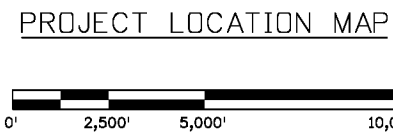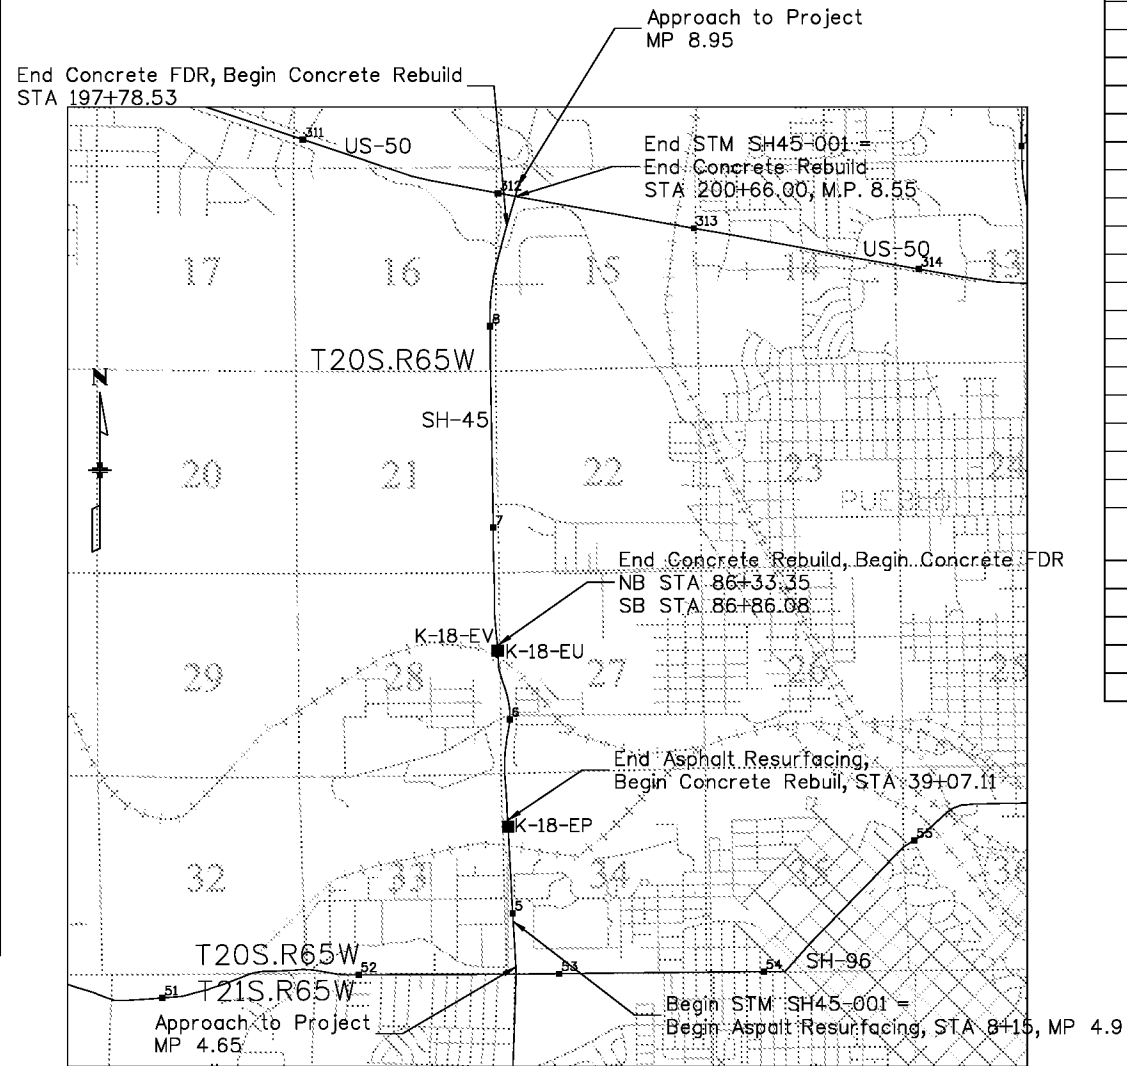

SHEET NO.	INDEX OF SHEETS
1	TITLE SHEET
2	STANDARD PLANS LIST SHEET
3 - 11	TYPICAL SECTION SHEET
12	CONCRETE COMPRESSION JOINT DETAIL
13	GENERAL NOTES
13-18	SUMMARY OF APPROXIMATE QUANTITIES
19	EARTHWORK QUANTITIES AND PAVEMENT DATA
20-23	SURFACE TABULATION SHEETS
24	TABULATION OF REMOVALS
25	TABULATION OF GUARDRAIL
26	TABULATION OF MISC AND DELINEATORS
27-28	GEOMETRY PLAN
29-42	REMOVAL AND RESET PLAN
43-49	ROADWAY PLAN SHEET
50-57	NORTHBOUND PLAN AND PROFILE
58-65	SOUTHBOUND PLAN AND PROFILE
66-71	SECONDARY PLAN AND PROFILE
72-80	GRADING PLAN SHEET
81-90	BRIDGE SHEETS
91-95	SWMP CONSTRUCTION PLAN SHEET
96-109	SWMP PLAN SHEET INTERIM AND FINAL
110	TABULATION OF TRAFFIC CONTROL DEVICES AND STRIPING
111	TABULATION OF SIGNING
112-113	TABULATION OF TRAFFIC DEVICES
114-124	TRAFFIC PLANS
124-133	SURVEY CONTROL DIAGRAM
134	SURVEY TABULATION



**Know what's below.  
Call before you dig.**

Print Date: 3/7/2017	<table border="1" style="width: 100%; border-collapse: collapse;"> <thead> <tr> <th colspan="3">Sheet Revisions</th> </tr> <tr> <th>Date:</th> <th>Comments</th> <th>Init.</th> </tr> </thead> <tbody> <tr><td> </td><td> </td><td> </td></tr> <tr><td> </td><td> </td><td> </td></tr> <tr><td> </td><td> </td><td> </td></tr> </tbody> </table>	Sheet Revisions			Date:	Comments	Init.										<p>Colorado Department of Transportation 902 Erie Avenue Pueblo, CO 81001 Phone: 719-562-5509 FAX: 719-546-5702 Region 2 DTD</p>	<p>As Constructed</p> <p>No Revisions:</p> <p>Revised:</p> <p>Void:</p>	Contract Information		Project No./Code
Sheet Revisions																					
Date:		Comments	Init.																		
File Name: 20755DES_TitleSht.dgn	Contractor:	STM SH45-001																			
Horiz. Scale: 1:1      Vert. Scale: As Noted	Resident Engineer:																				
Unit Information      Unit Leader DTD	Project Engineer:																				
	PROJECT STARTED: / /      ACCEPTED: / /																				
	Comments:	20755	Sheet Number	1																	

philips11:3:19 PM c:\projectwise\pwrz\working\cd\328826\_20755DES\_TitleSht.dgn