



Sheet Revisions		
Date	Description	Initials
mm/dd/yy	XXXXXXXX	XXX

Sheet Revisions		
Date	Description	Initials
mm/dd/yy	XXXXXXXX	XXX

Sheet Revisions		
Date	Description	Initials
mm/dd/yy	XXXXXXXX	XXX




Project Control Diagram			
Plan Sheet			
Project Number:			
Project Location: State Highway 45 (Pueblo Blvd.)			
Goodnight Ave. to SH 50			
Project Code:	Last Mod. Date	Subset	Sheet No.
20755	09-10-15	3.08 of 3.10	3.08

DEPARTMENT OF TRANSPORTATION

STATE OF COLORADO

PROJECT CONTROL DIAGRAM

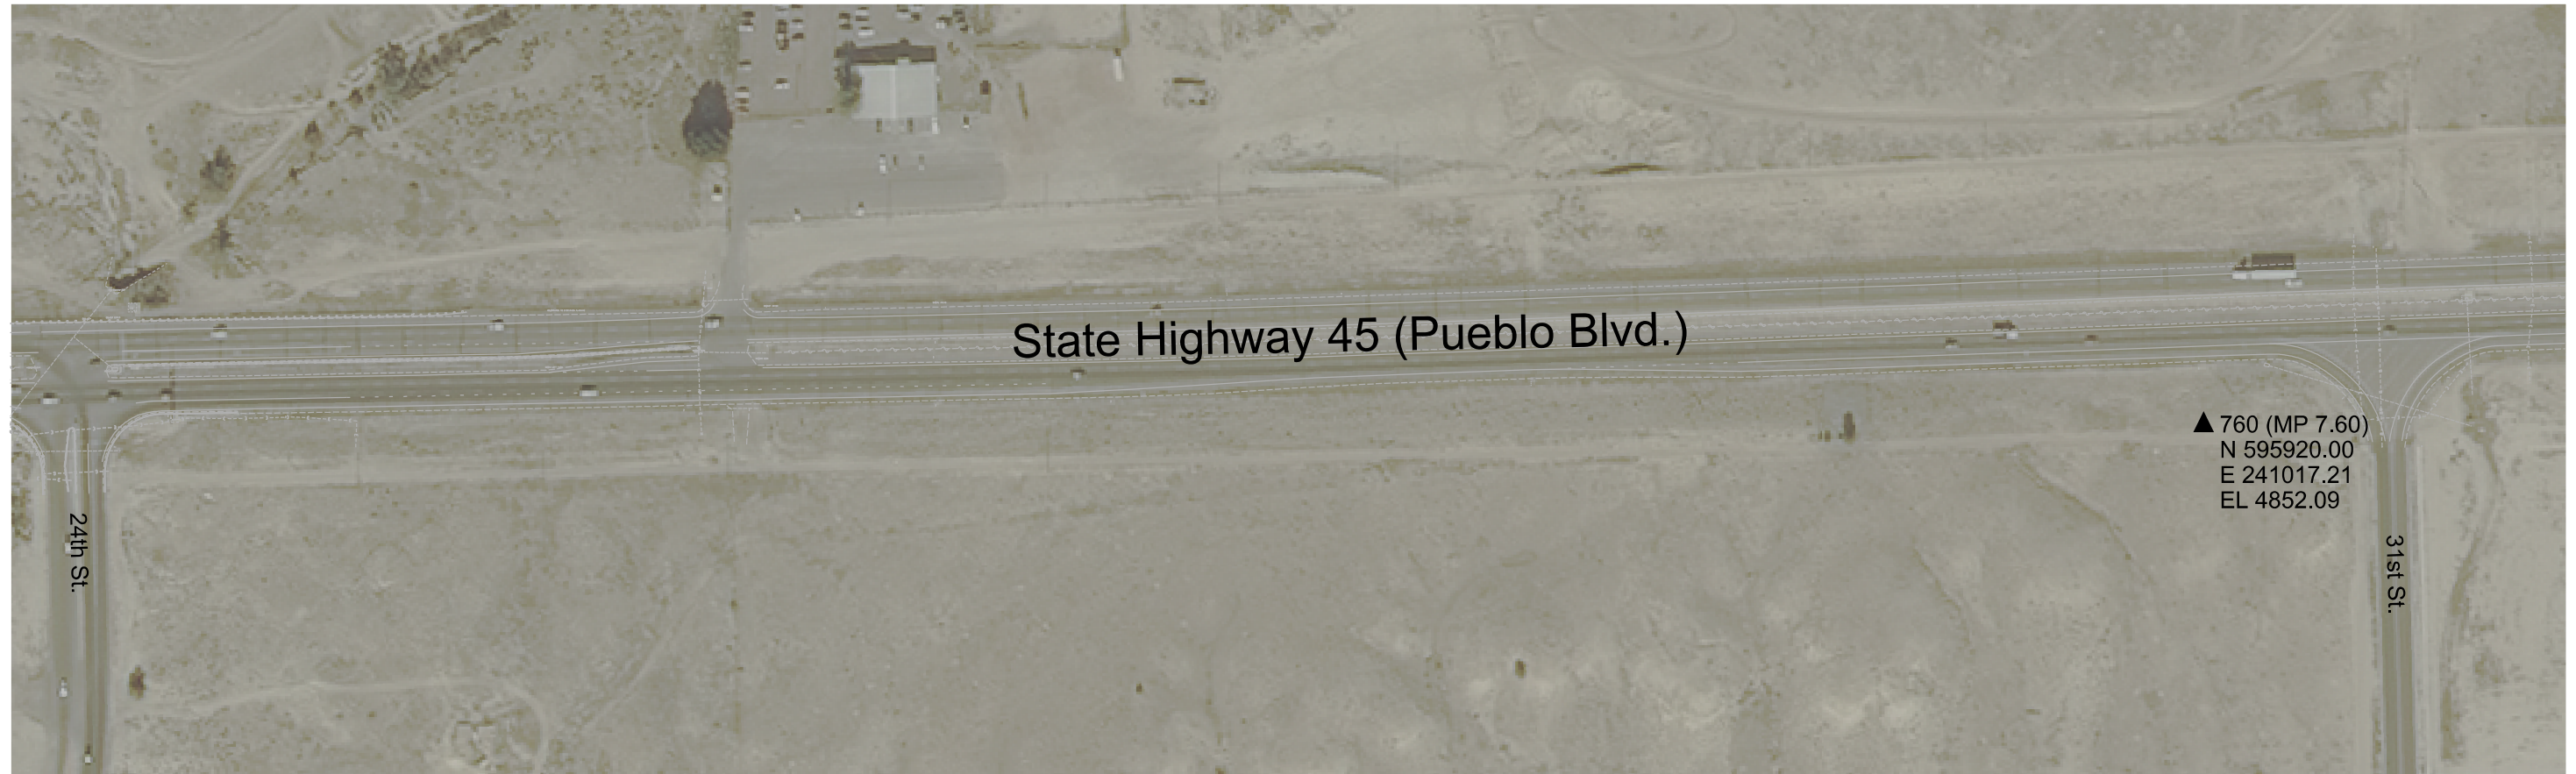

State Highway 45 (Pueblo Blvd.)

▲ 760 (MP 7.60)
N 595920.00
E 241017.21
EL 4852.09

24th St.

31st St.

